


	1	2	3	4	5	6	7	8	9	10	11	12	13	14	15
STREAM No.	1	2	3	4	5	6	7	8	9	10					
PRODUCT	LIMESTONE	LIMESTONE	GYPSUM	GYPSUM											
CAPACITY tph	1440	1200	700	1150											
DENSITY kg/m <sup>3</sup>	1360	1360	1000	1000											

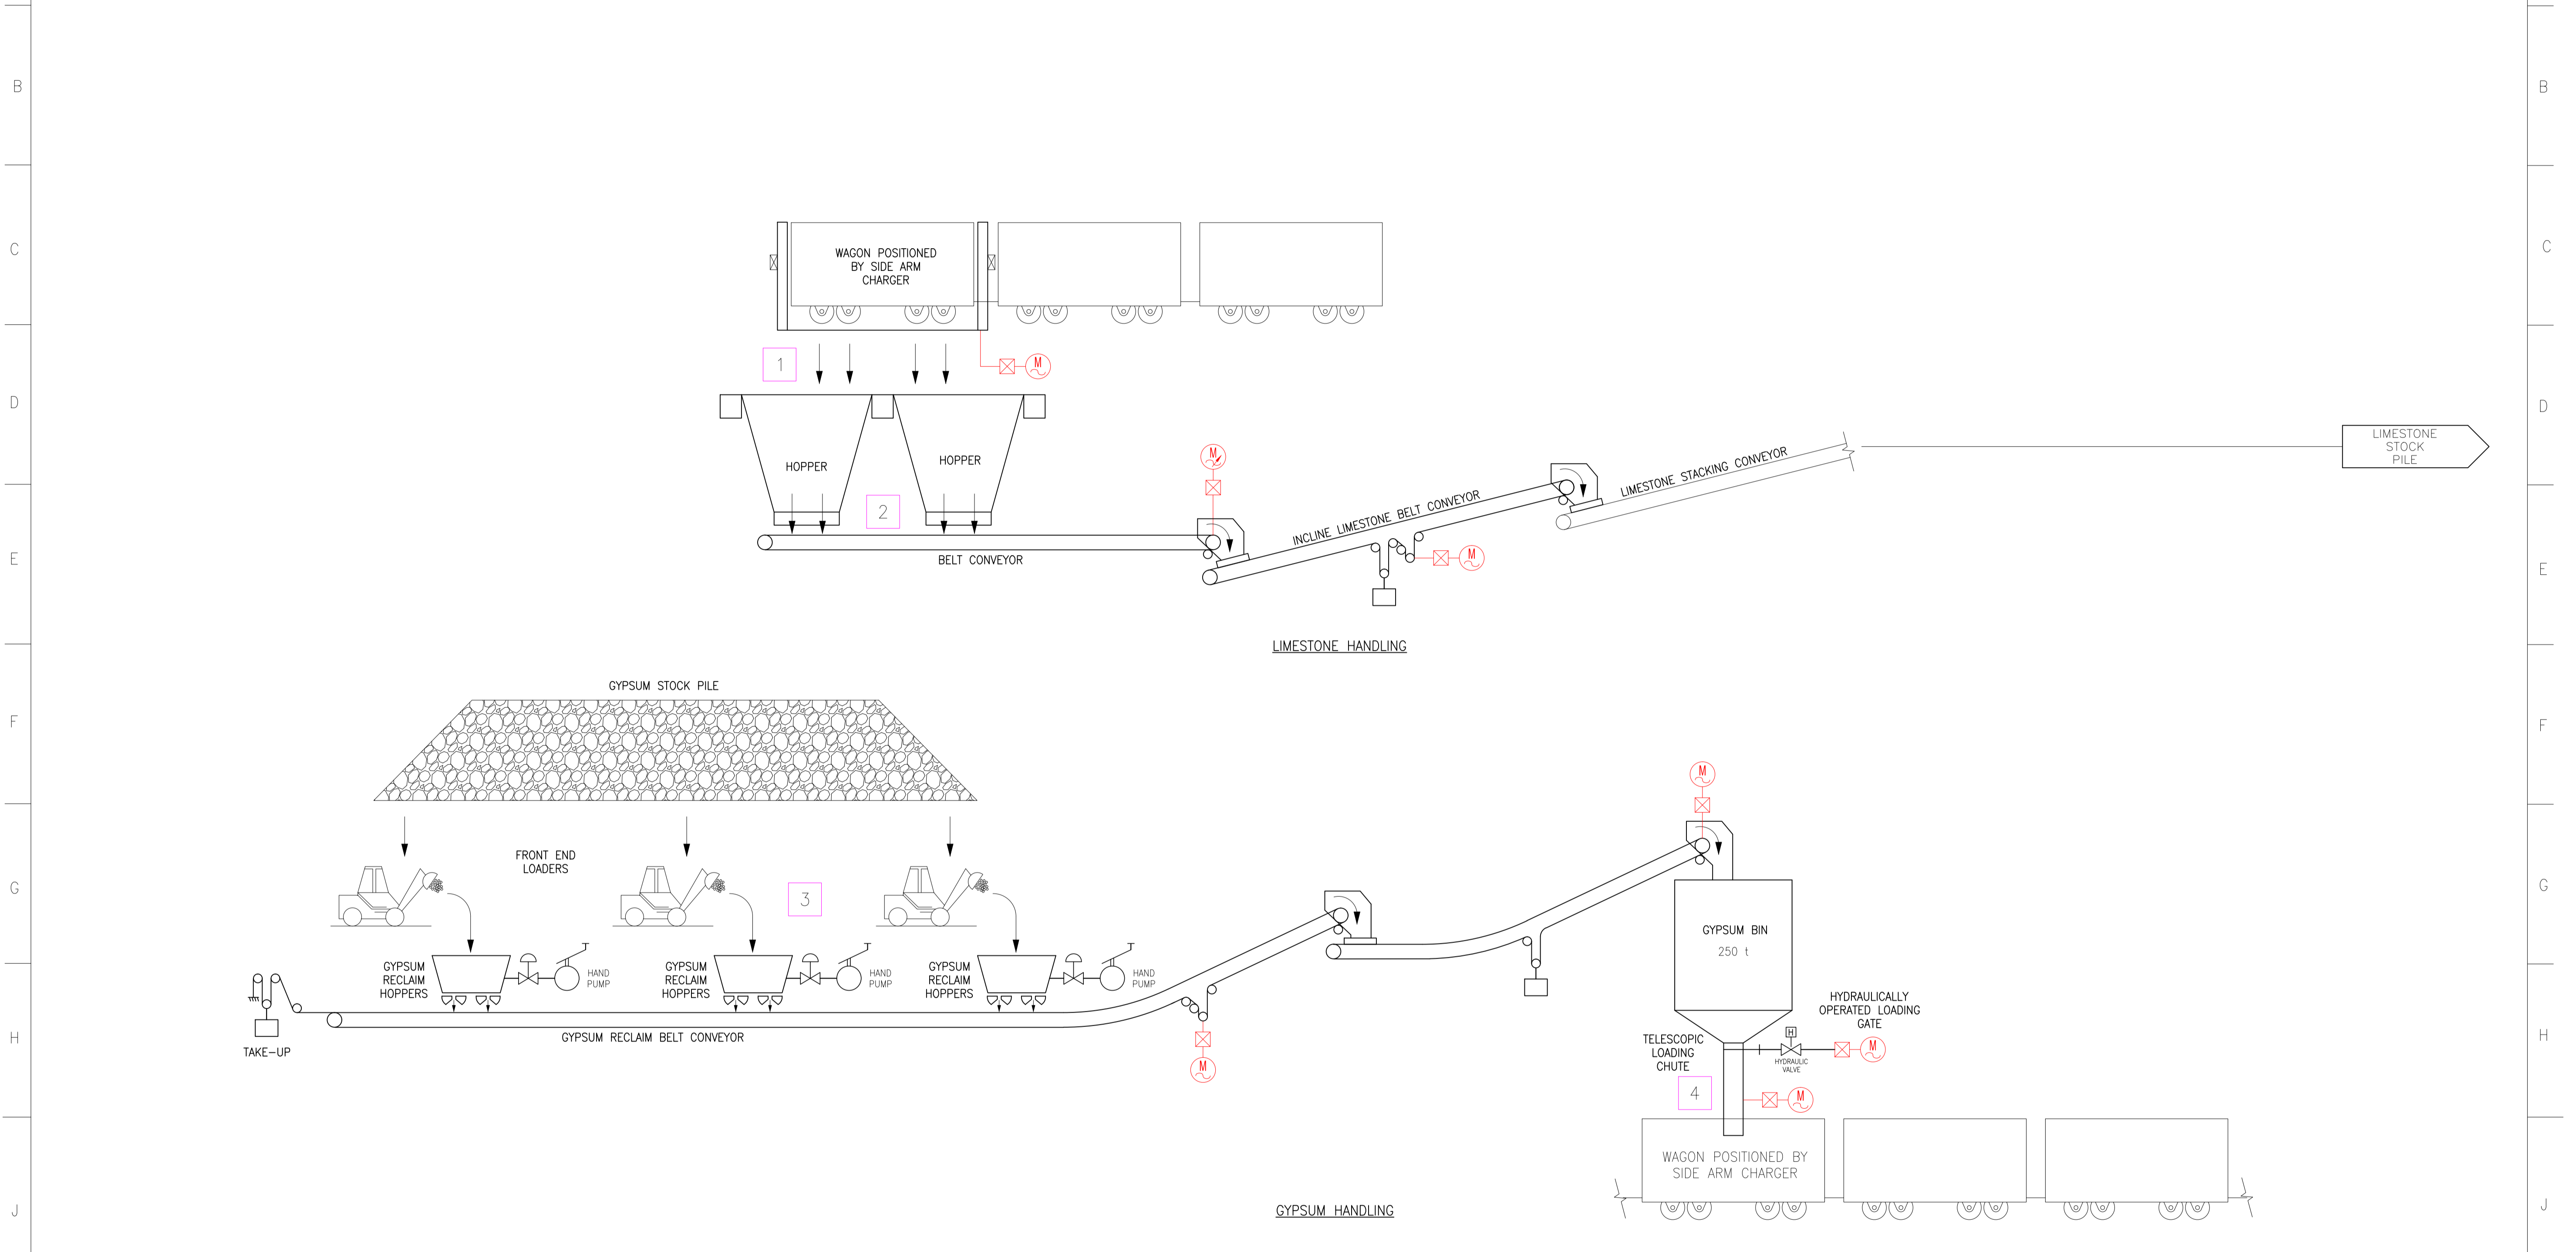

K.N. 02	25/08/15	ISSUED FOR TENDER	LRM	K.N.	D.B.						
K.N. 01	29/05/15	ISSUED FOR CLIENT APPROVAL	LRM	K.N.	D.B.						
K.N. 1	29/05/15	INTERNAL REVIEW	LRM	K.N.	D.B.						
D.O.	REV	DATE	REVISION			REV BY	CHKD BY	APP BY	AUTH BY	KKS APP	REFERENCE DRAWINGS
AUTHORISED FOR ESKOM BY:		SPF CODE									
CODIFICATION BY:		PBS PATH									
APPROVED BY:											
D. Bezuidenhout		29/05/2015									
CHECKED BY:		29/05/2015									
CREATED BY:		29/05/2015									
L. Marais		29/05/2015									
SCALE		NTS									
				<b>MEDUPI POWER STATION</b> <b>RAILWAY YARD</b> <b>MATERIALS HANDLING LAYOUT</b> <b>PROCESS FLOW DIAGRAM</b>							
				CONTRACTOR DRAWING NO <b>1184-099-5-100-PR-0002</b>				REV 02			
				ESKOM DRAWING NO <b>0.84/44352</b>				SHT 1 OF 1 REV 0			
				ESKOM HOLDINGS LTD. REG. NO. 2002/016527/06							